




Legend

Precinct boundary

Precinct Plan Rockbank Site Plan				Date		4/6/2013	Sheet		1	of	1	
				Drawing No.		139029P00 SITE			Version 1			
				CAD Ref.		E:\JOBS\1009 ROCKBANK PSP\CAD FILES\ACAD						
				Drawn By		ES		Checked By		SN		
Co-ordinate Datum				Scale A3								
MGA55				1 : 40000		<div><div><div>400</div><div>0</div><div>400</div><div>800</div><div>1200</div></div><div>Lengths are in metres</div></div>						
REV				AMENDMENT		APPROVED DATE						

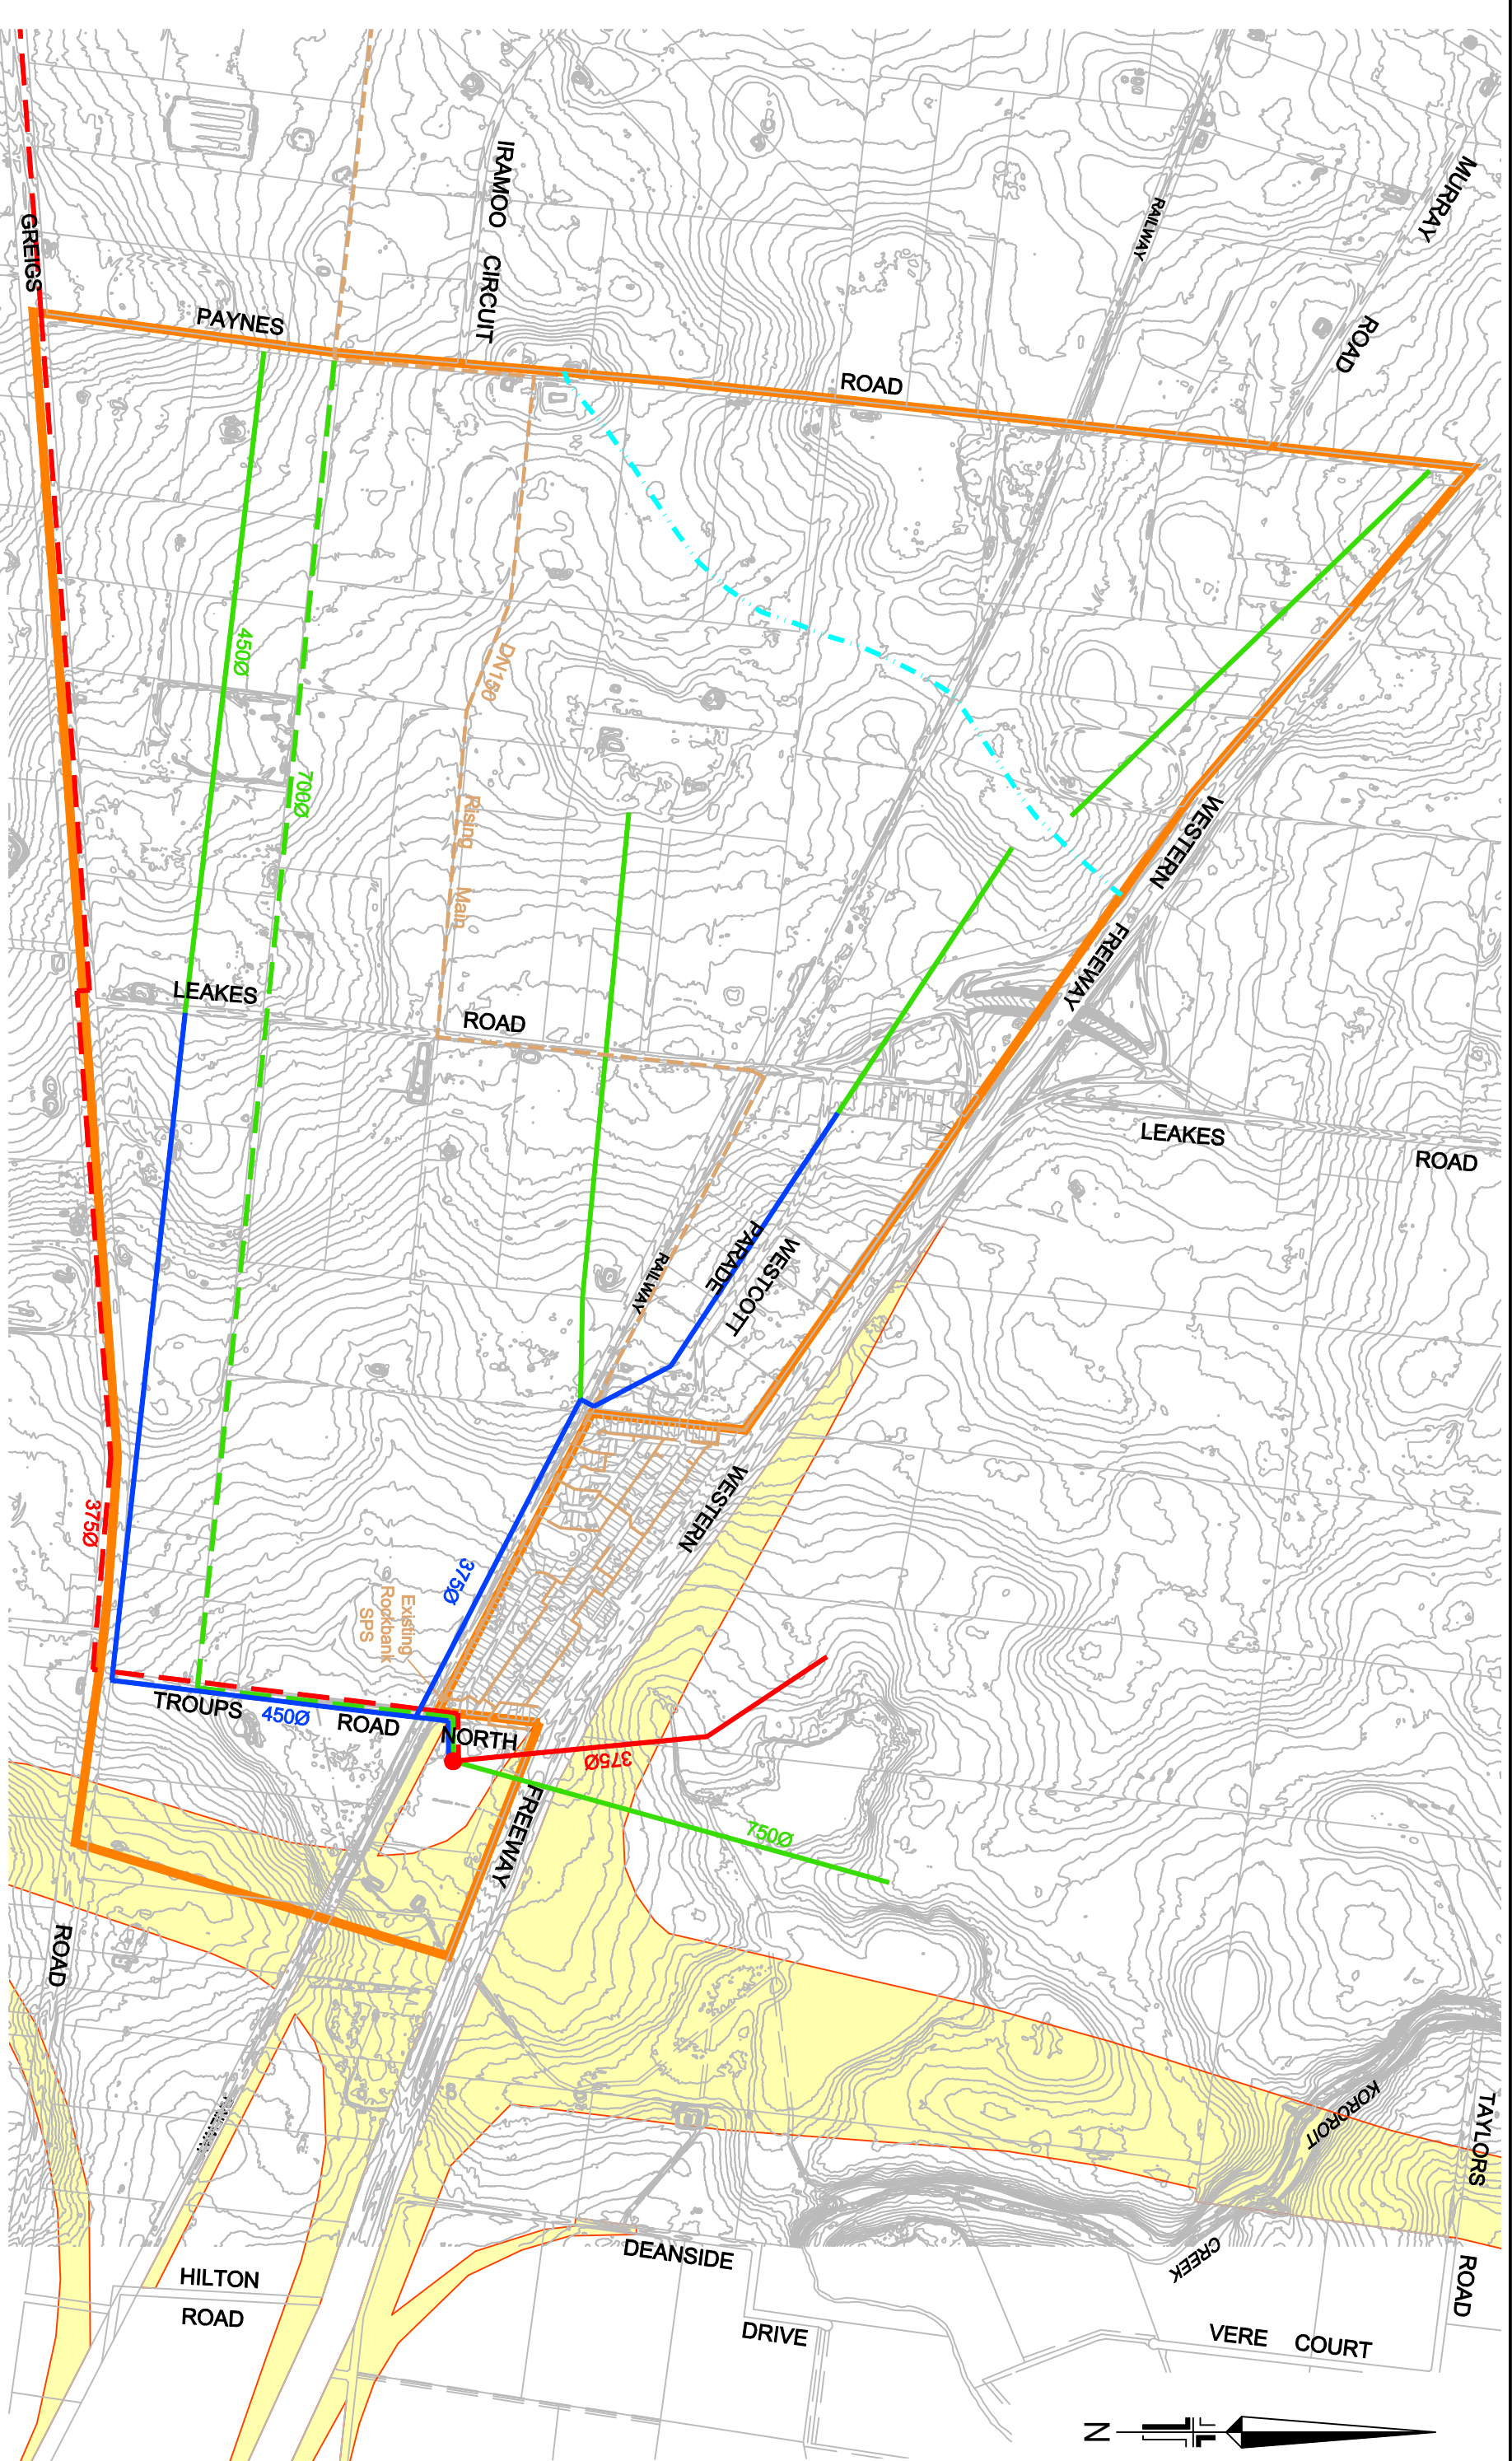

Legend

- Precinct boundary
- Existing Sewer / Rising Main / Pump Station
- WP3 Sewer / Rising Main / Pump Station
- WP4 Sewer / Rising Main
- Future Sewer / Rising Main
- Approximate Catchment Boundary

Note : Contour Interval 0.5m

Precinct Plan

Rockbank

Indicative Sewer Layout

Co-ordinate Datum

MGA55

Scale A3

1 : 15000


150 0 150 300 450

Lengths are in metres

Date	30/4/2013	Sheet	1	of	1
Drawing No.	139029P00 SEWER	Version	2		
CAD Ref.	E:\JOBS\1009 ROCKBANK PSP\CAD FILES\ACAD				
Drawn By	ES	Checked By	SN		
REV	AMENDMENT	S.N.	15-09-2013		
2	Indicative alignment amendments				



445 Townsend Street  
PO Box 3400  
Albury NSW 2640  
T 61 2 6051 1300  
spire.com.au

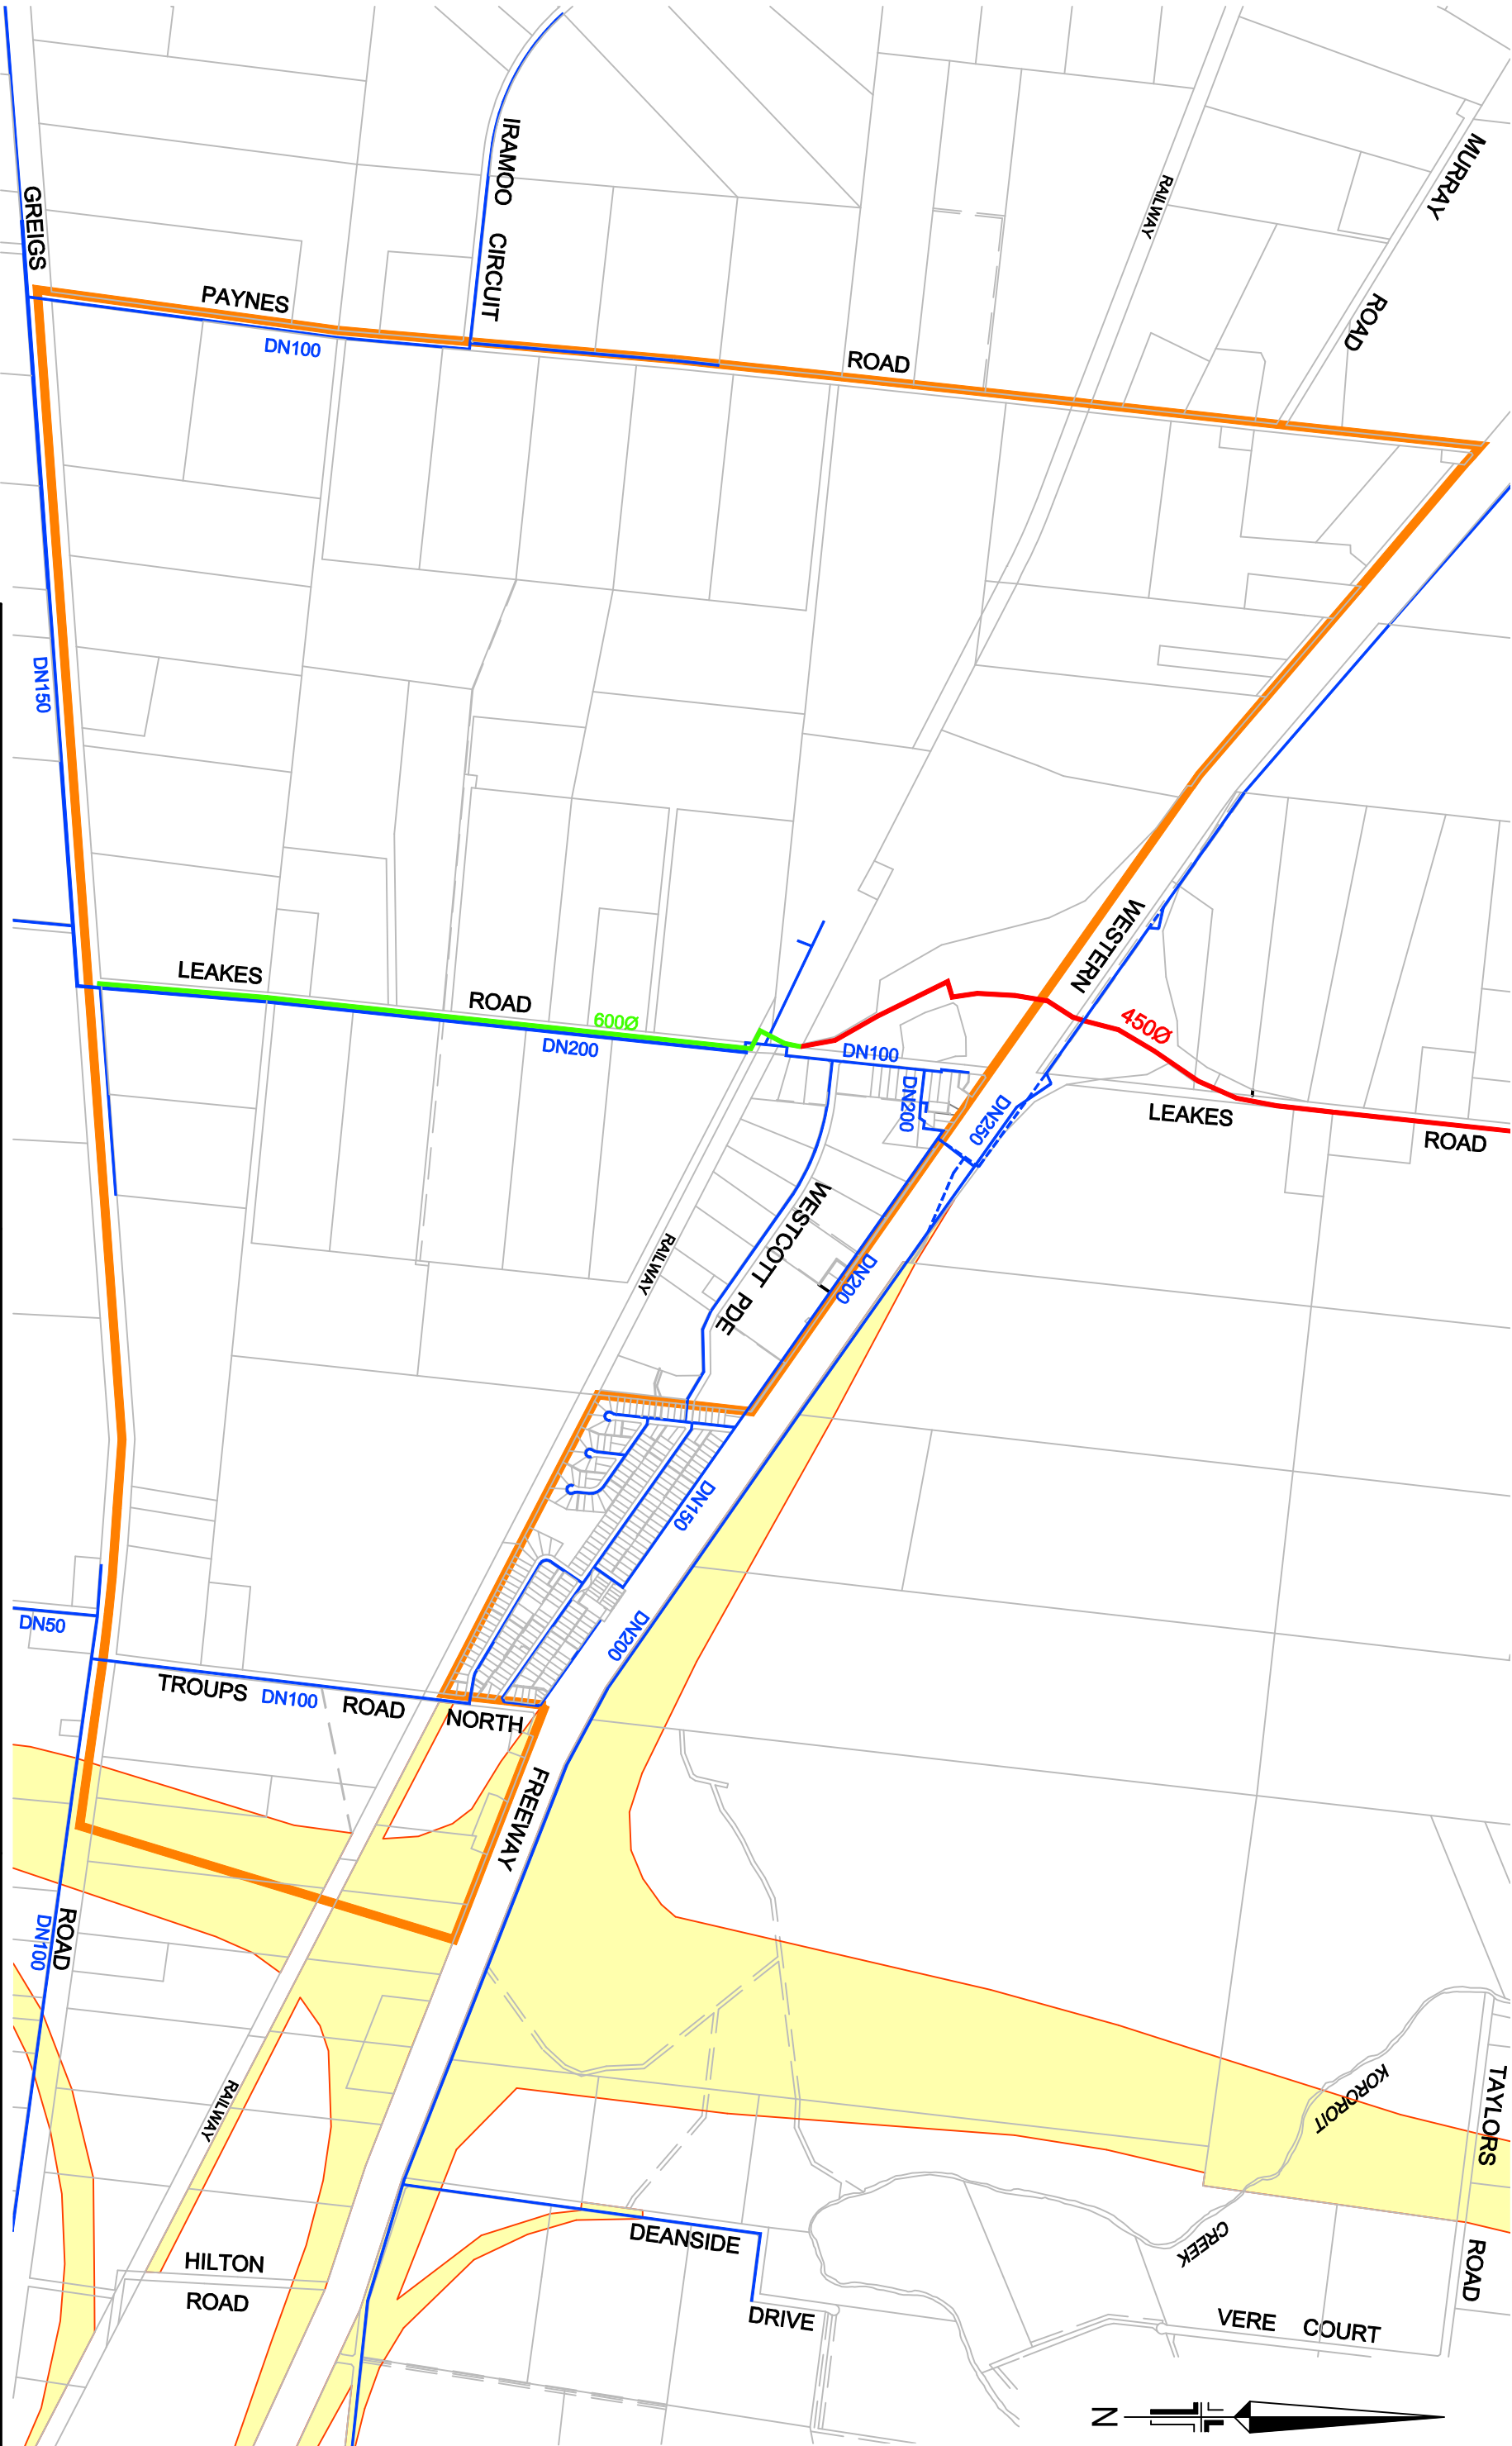

- Legend
- Precinct boundary
  - Existing Water Main
  - Proposed Trunk Water (WP5 2023-2027 or beyond)
  - Proposed Trunk Water (WP5 2023-2027 or beyond)

Precinct Plan  
Rockbank  
Indicative Potable Water Layout

Co-ordinate Datum  
MGA55

Scale A3  
1 : 15000

1500 0 1500 3000 4500

Lengths are in metres

Date	30/4/2013	Sheet	1	of	1
Drawing No.	139029P00 WATER	Version	2		
CAD Ref.	E:\JOBS\1009 ROCKBANK PSP\CAD FILES\ACAD				
Drawn By	ES	Checked By	SN		
REV	AMENDMENT	S.N.			
2	Update legend and extent of WP3 works	16-09-2013			

spire

Innovation in Infrastructure

445 Townsend Street  
PO Box 3400  
Albury NSW 2640  
T 61 2 6051 1300  
spire.com.au



Legend

- Precinct boundary
- Proposed Trunk Recycled Water (WP3 2013-2017)
- Proposed Trunk Recycled Water (WP4 2018-2023)
- Proposed Trunk Recycled Water (Beyond WP4)

Precinct Plan  
Rockbank  
Indicative Recycled Water Layout

Co-ordinate Datum  
MGA55

Scale A3  
1 : 15000

1500 0 1500 300 450


Lengths are in metres

Date	30/4/2013	Sheet	1	of	1
Drawing No.	139029P00 RECYCLED WATER	Version 2			
CAD Ref.	E:\JOBS\1009 ROCKBANK PSP\CAD FILES\ACAD				
Drawn By	ES	Checked By	SN		
REV	Legend updated future services added	AMENDMENT	S.N.	15-09-2013	APPROVED DATE
2					

spire

Innovation in Infrastructure

445 Townsend Street  
PO Box 3400  
Albury NSW 2640  
T 61 2 6051 1300  
spire.com.au

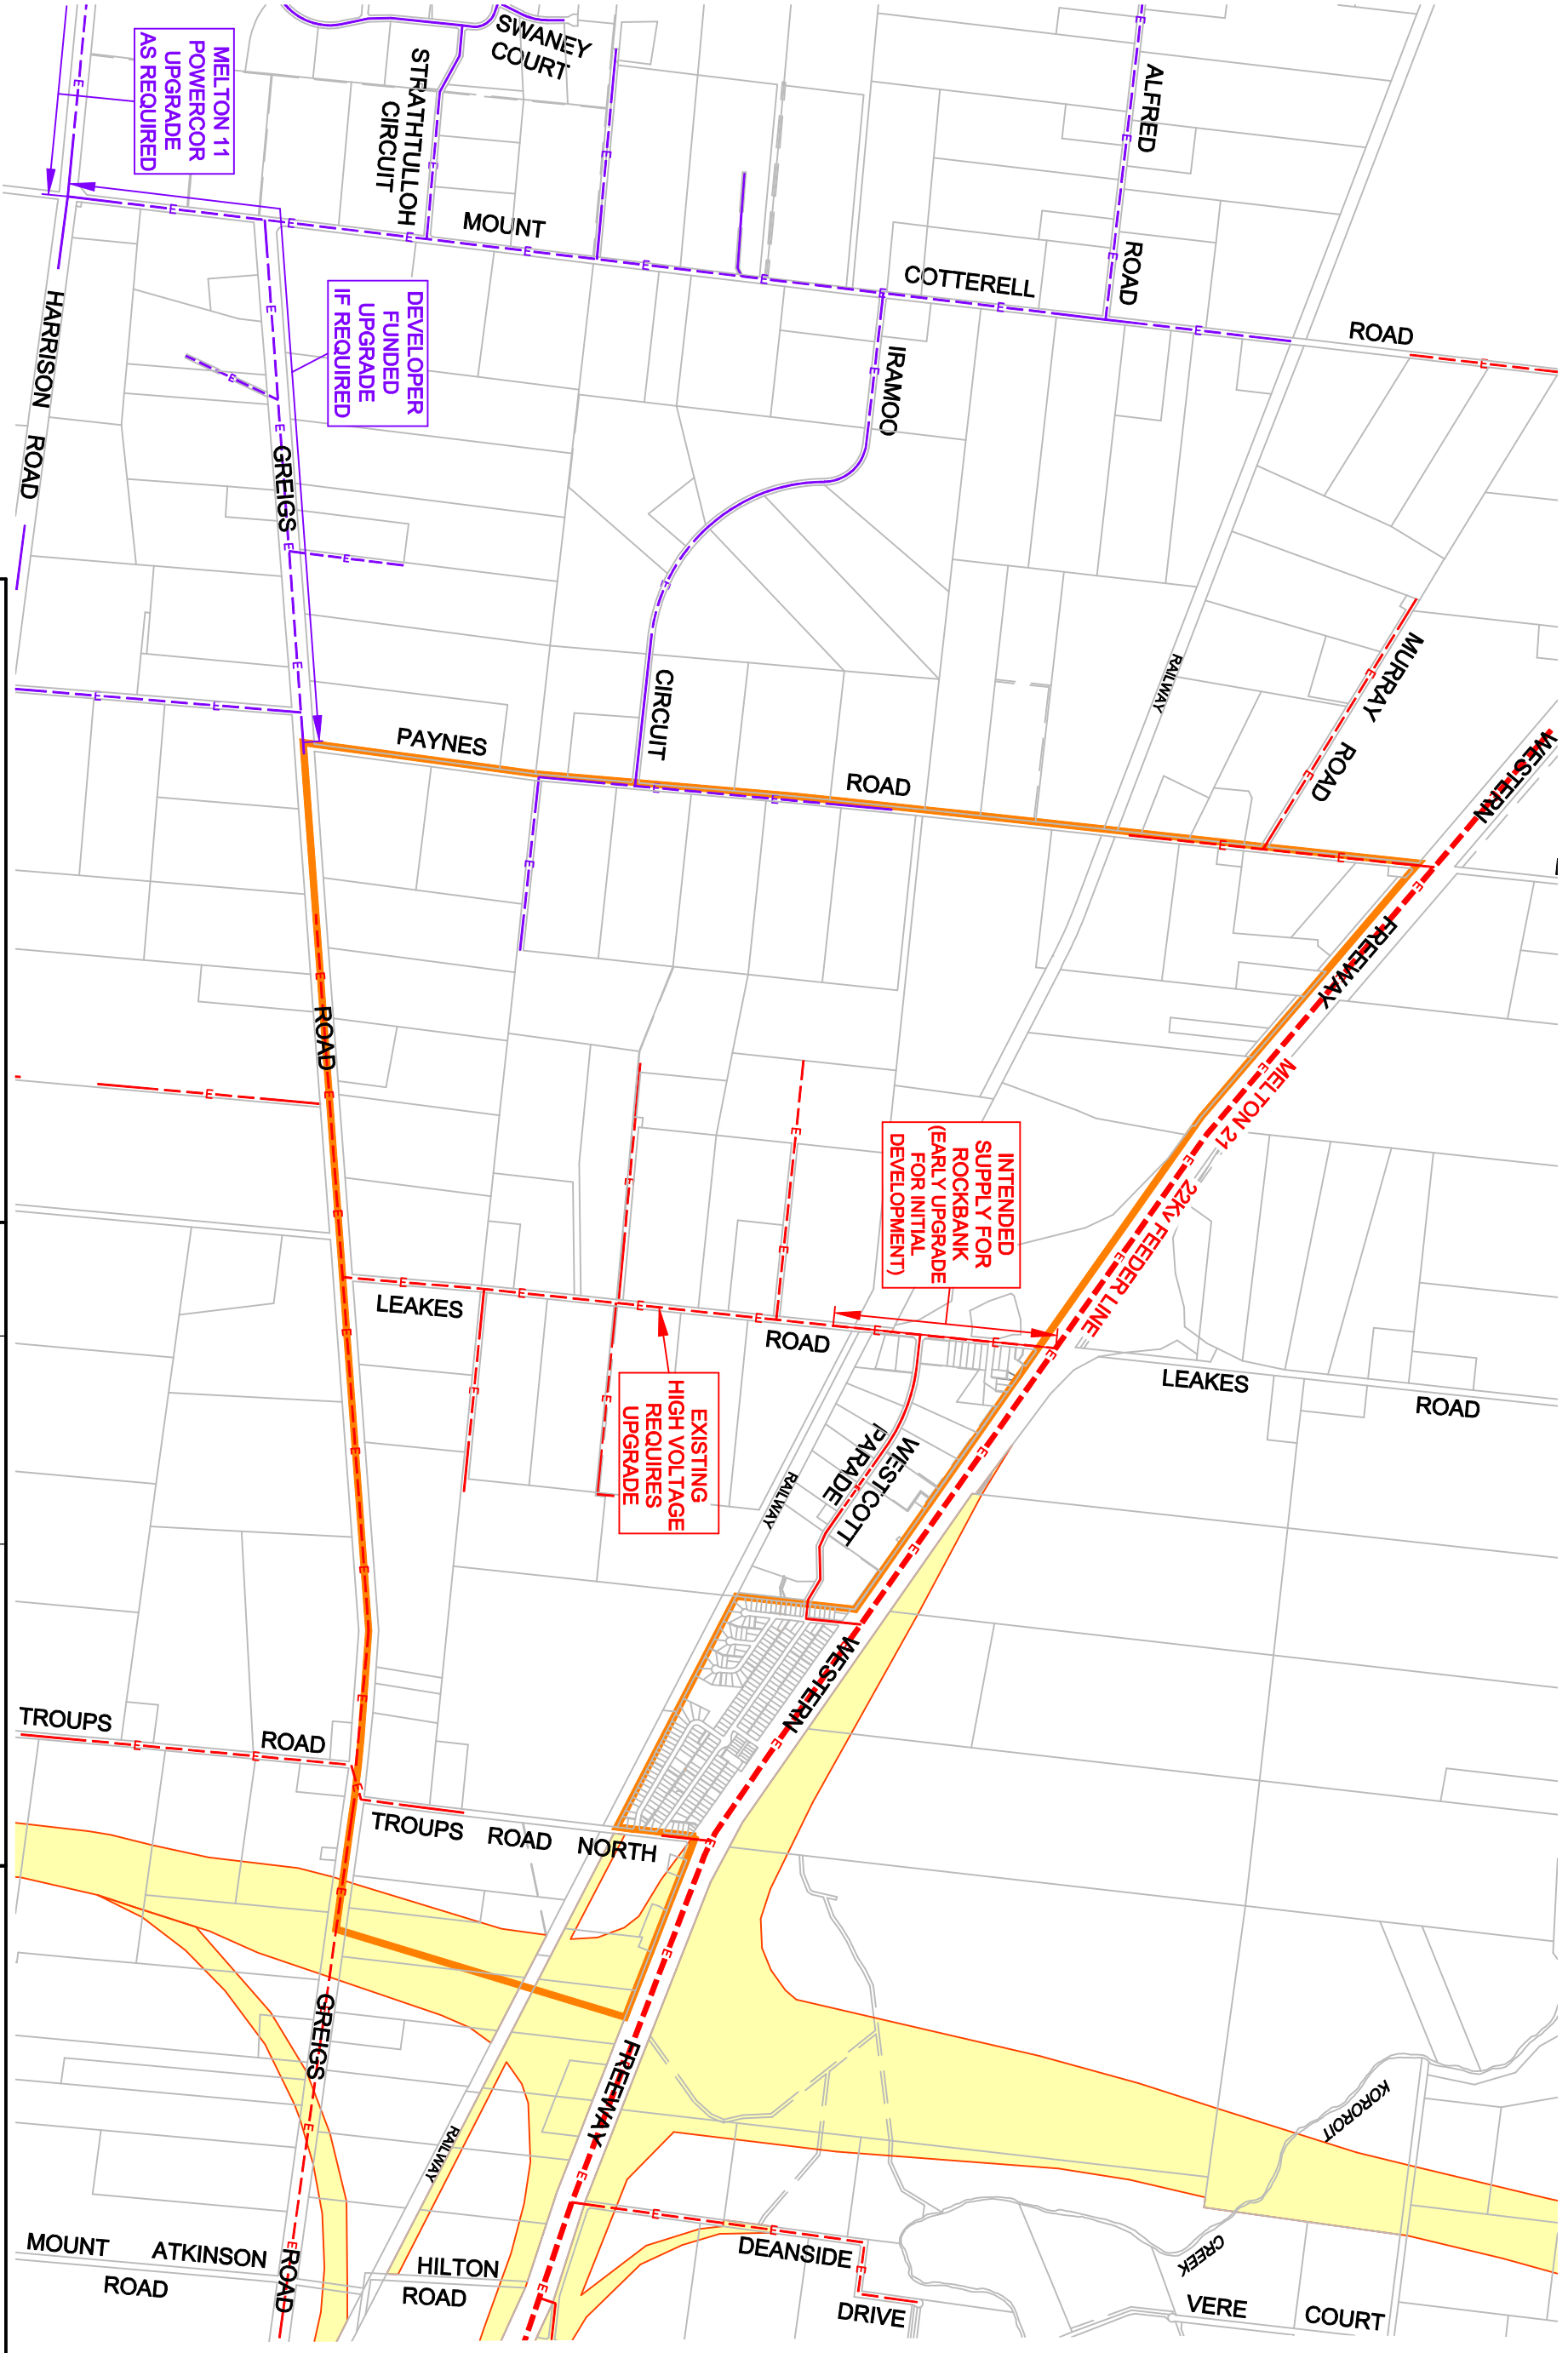

Legend

- Precinct boundary
- Melton 11 System
- Melton 21 System

Precinct Plan  
Rockbank  
Indicative Electrical Layout


Co-ordinate Datum  
MGA55

Scale A3  
1 : 20000

Lengths are in metres

Date	15/5/2013	Sheet	1	of	1
Drawing No.	139029P00 ELECTRICITY		Version 1		
CAD Ref.	E:\JOBS\1009 ROCKBANK PSP\CAD FILES\ACAD				
Drawn By	ES	Checked By	SN		
REV	AMENDMENT	APPROVED	DATE		

445 Townsend Street  
PO Box 3400  
Albury NSW 2640  
T 61 2 6051 1300  
spire.com.au

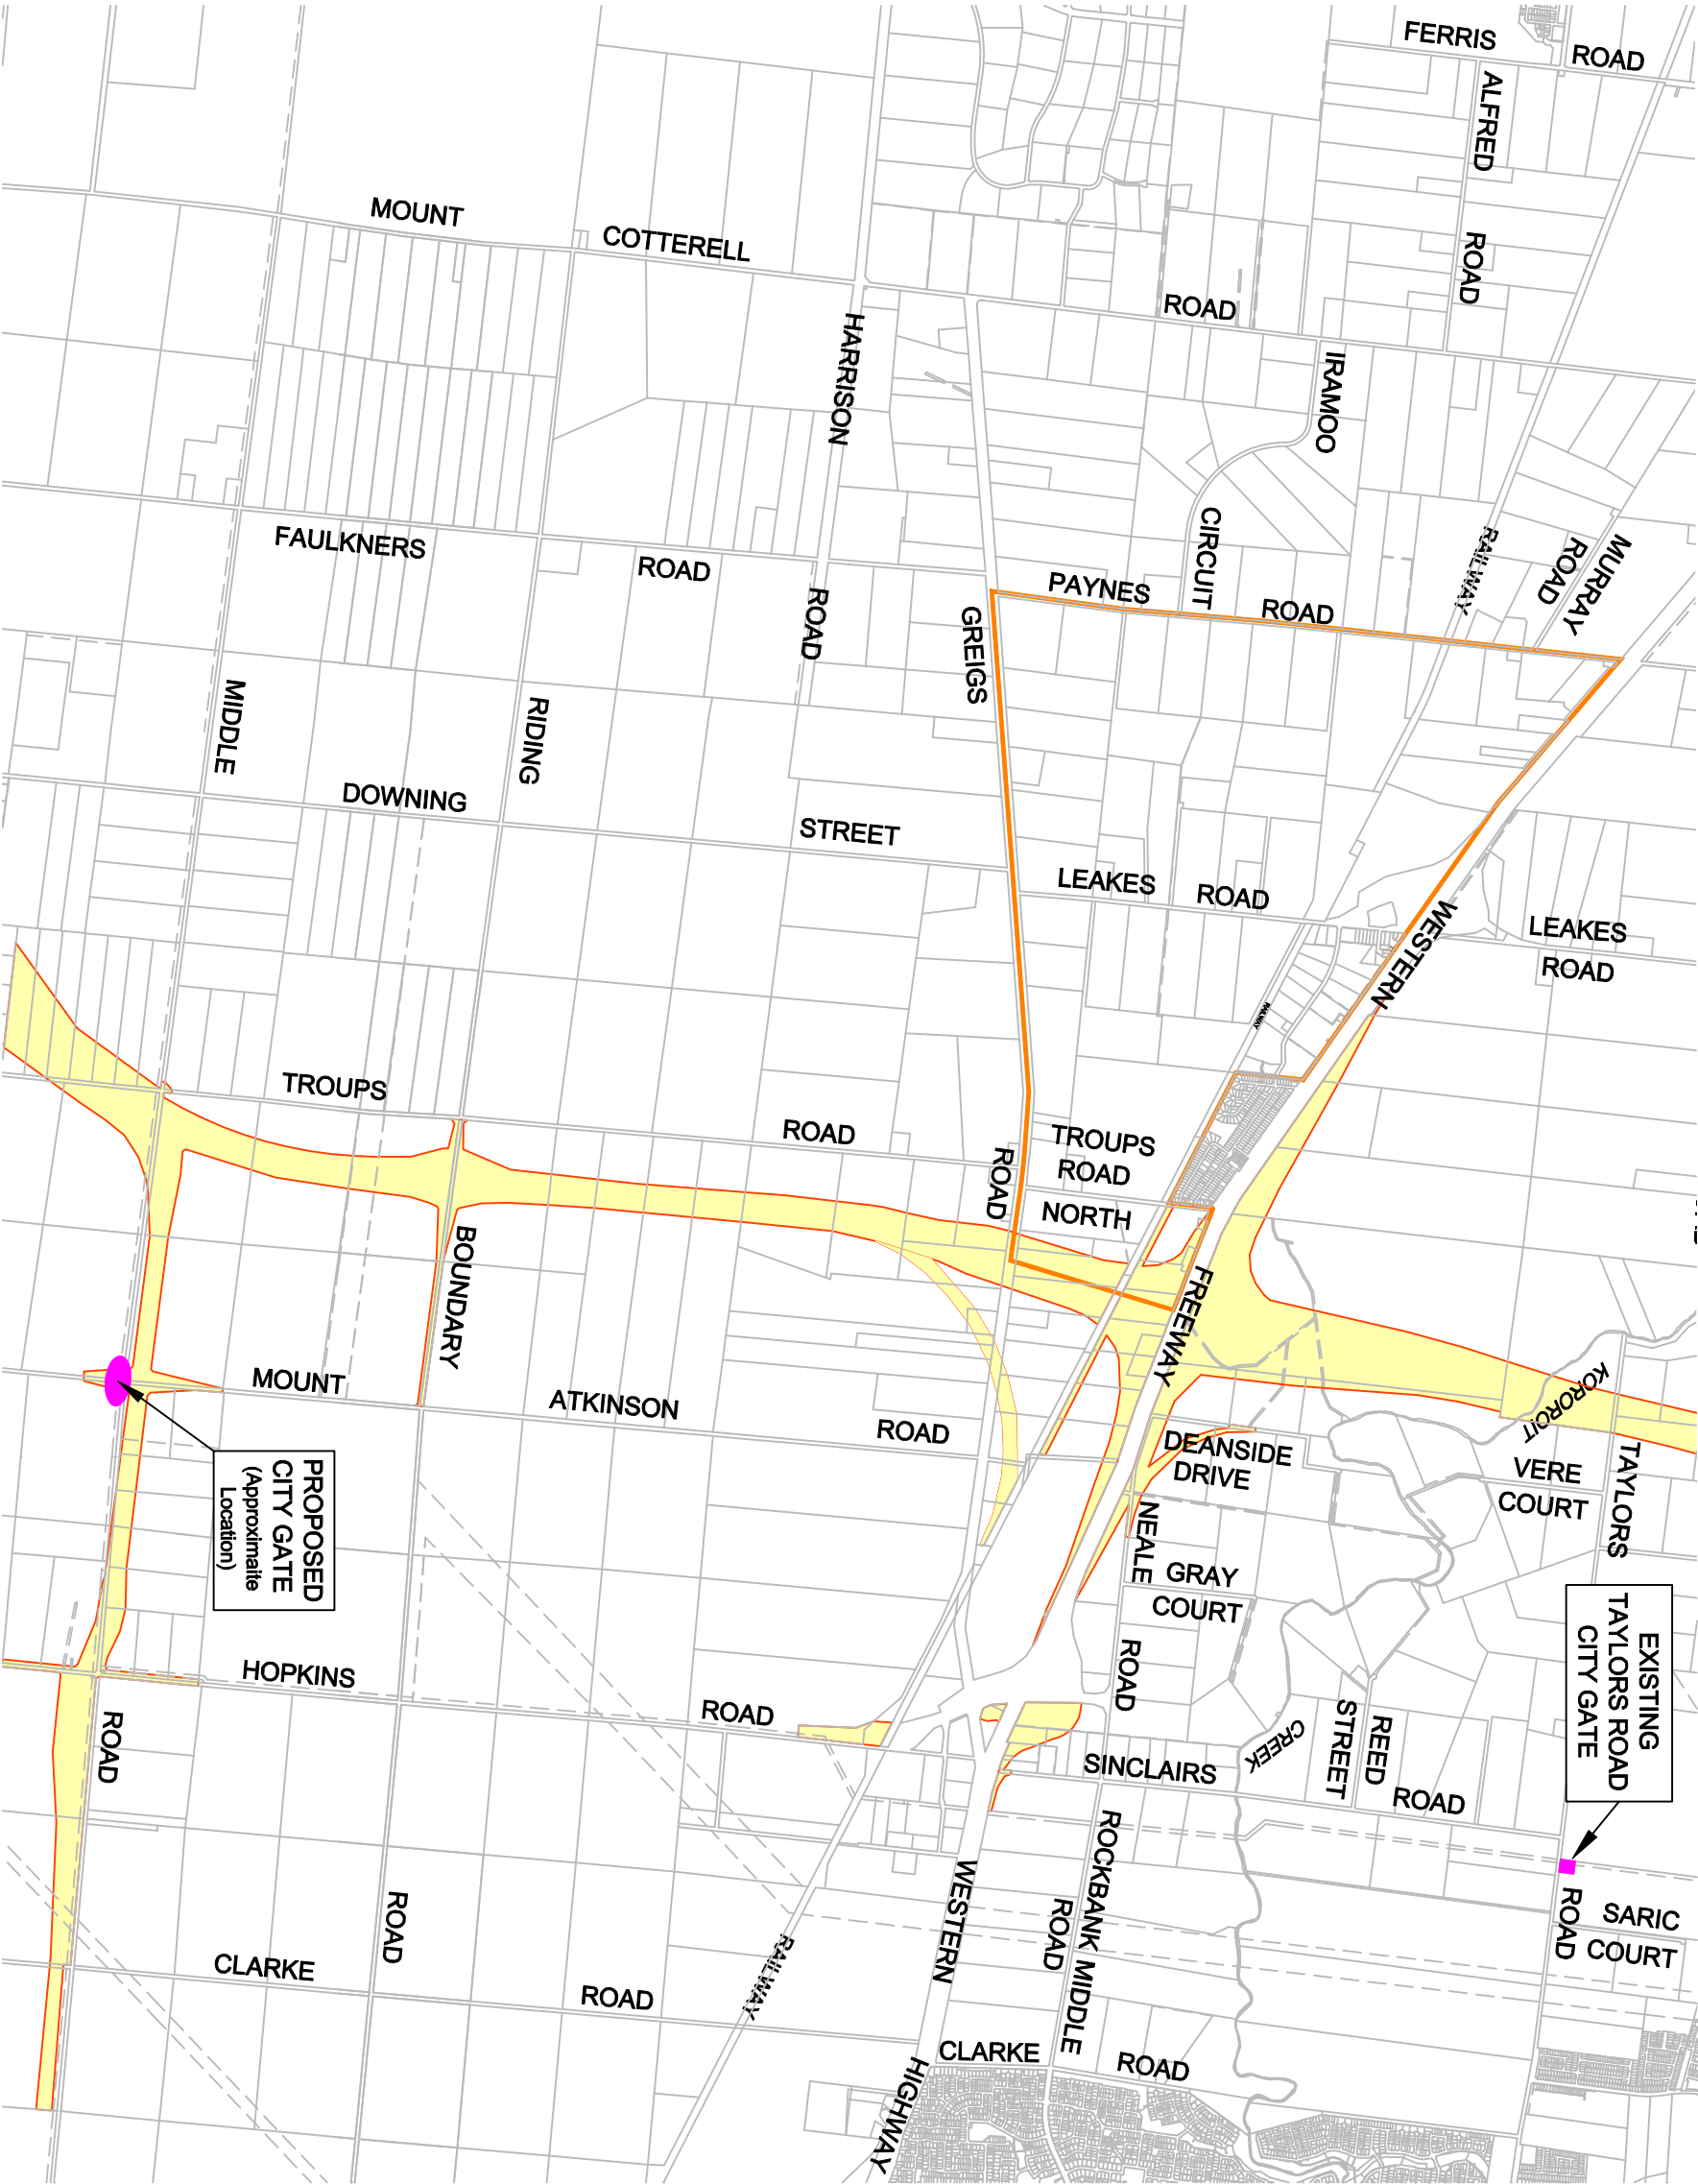

Precinct Plan		Date	3/4/2013	Sheet	1	of	1
Rockbank		Drawing No.	139029P00 GAS				Version 1
Gas Supply		CAD Ref.	E:\JOBS\1009 ROCKBANK PSP\CAD FILES\ACAD				
		Drawn By	ES	Checked By	SN		
		REV	AMENDMENT	APPROVED	DATE		

Co-ordinate Datum  
MGA55



Scale A3  
1 : #####

400 0 400 800 1200  
Lengths are in metres

spire

Innovation in Infrastructure

445 Townsend Street  
PO Box 3400  
Albury NSW 2640  
T 61 2 6051 1300  
spire.com.au

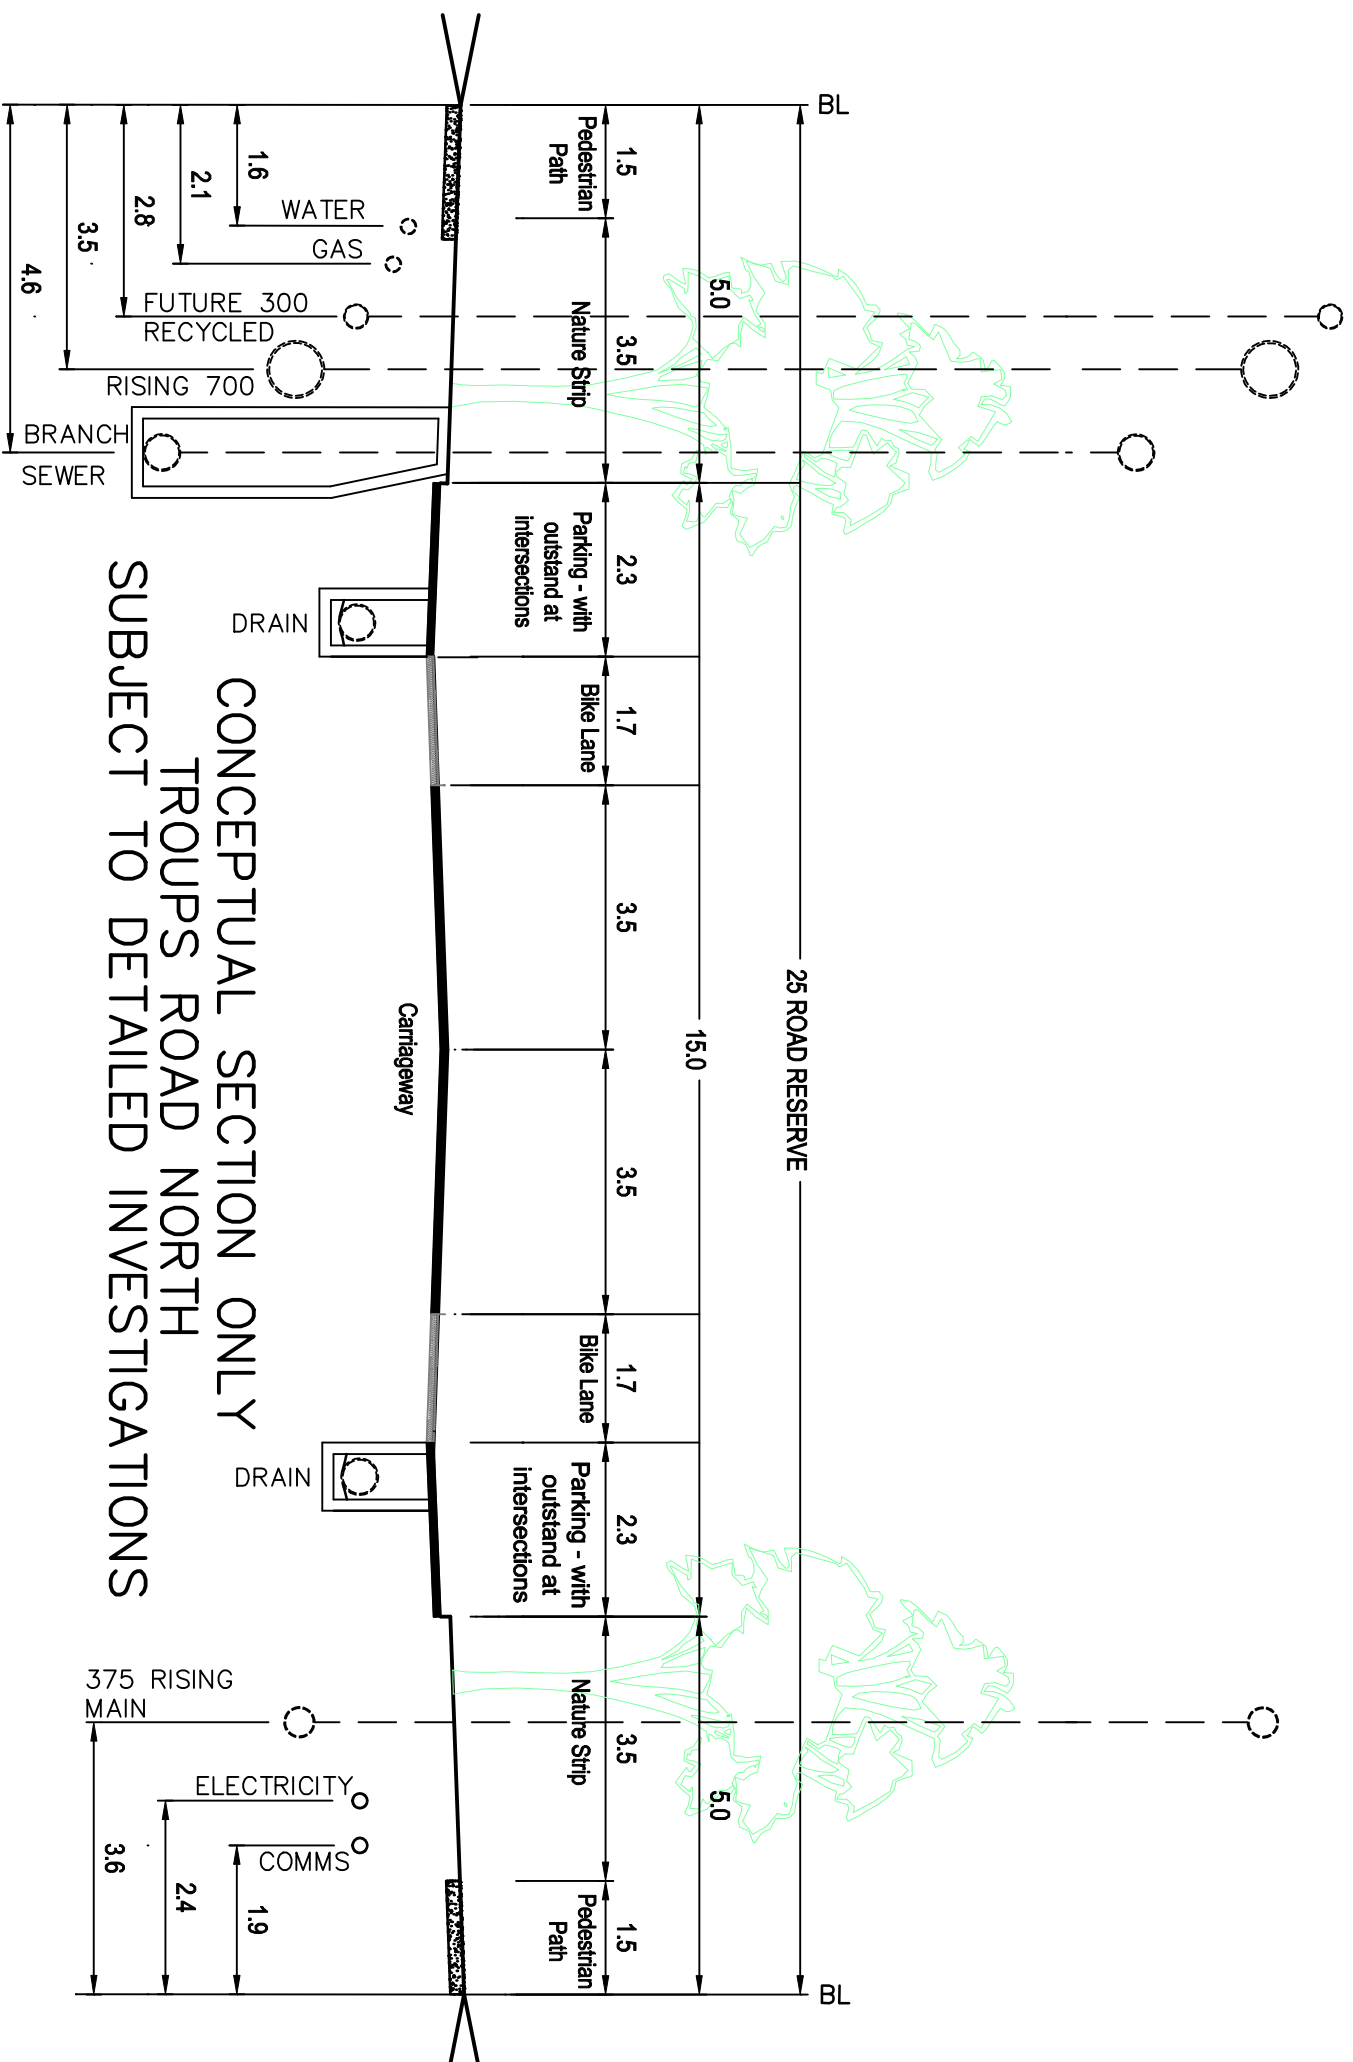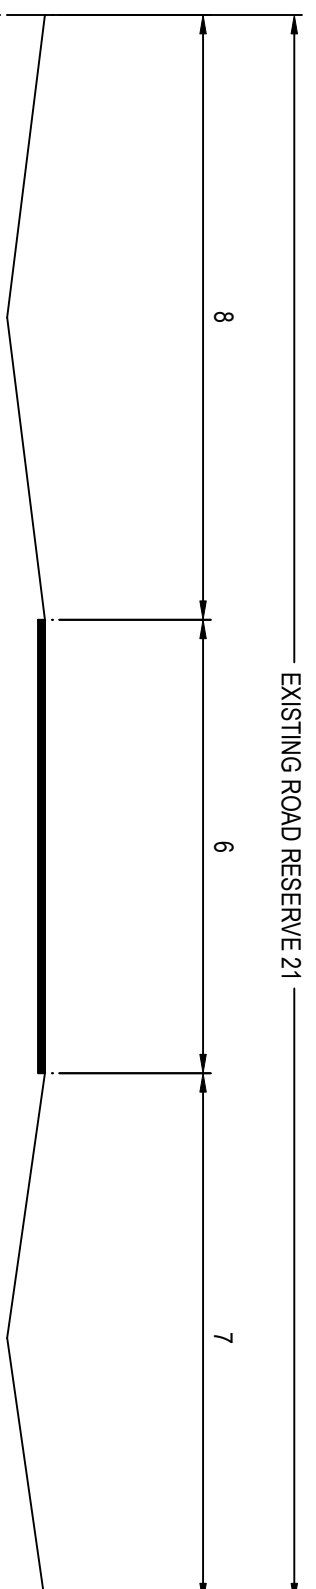

Precinct Plan					
Rockbank					
Connector Street - Residential					
Co-ordinate Datum	Scale A3 1 : 100	<p>Lengths are in metres</p>			
MGA55					
Date	18/10/2013	Sheet	1	of	1
Drawing No.	139029PD0 TYPICAL		Version	1	
CAD Ref.	E:\JOBS\1009 ROCKBANK PSP\CAD FILES\ACAD				
Drawn By	ES	Checked By	SN		
REV	AMENDMENT	APPROVED	DATE		

